




ARCHITECTURE PLANNING INTERIOR DESIGN
 15810 PARK TEN PLACE, SUITE 300
 HOUSTON, TEXAS 77084
 713-465-4650
 www.sligroup.com

Shell Federal
 CREDIT UNION
 26620 FM 1093 RD
 KATY, TEXAS 77494


Project Number : 8825

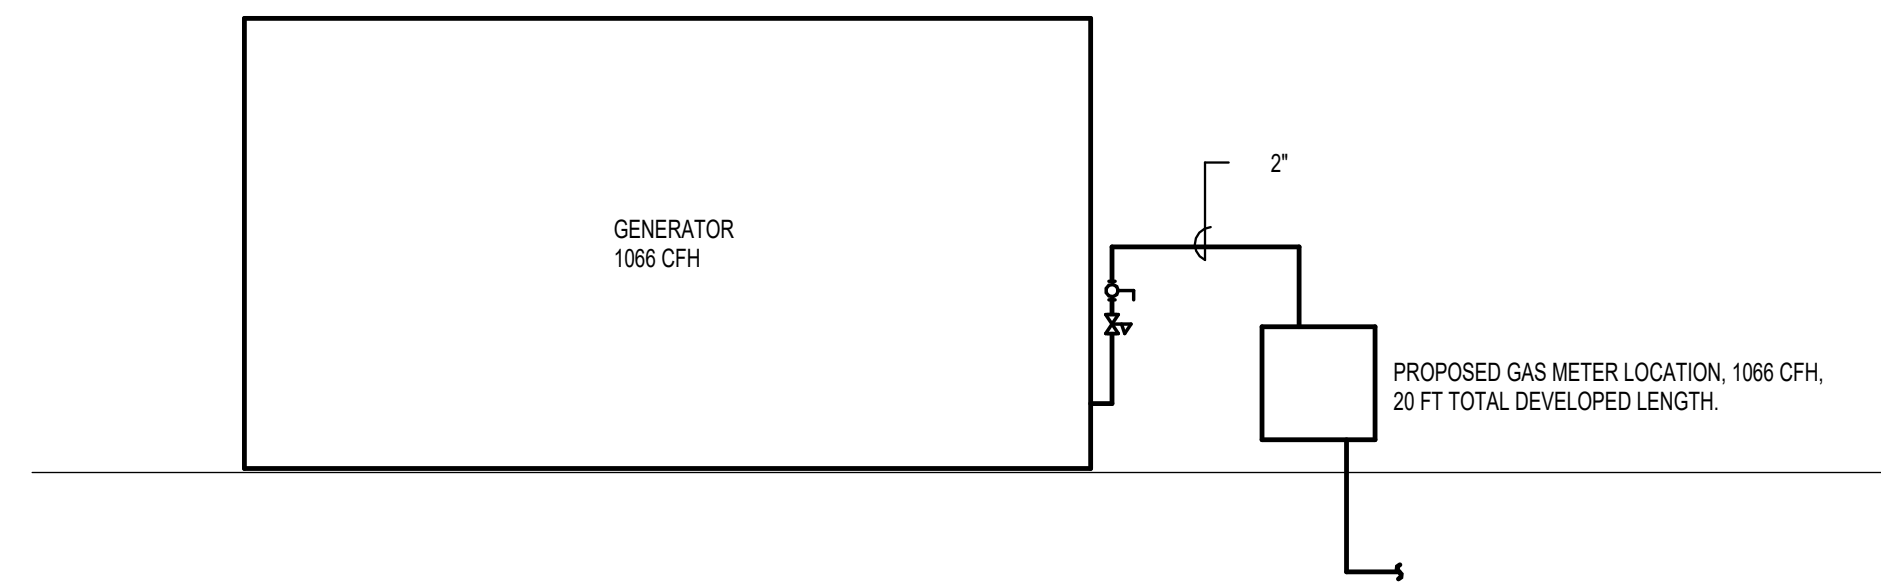

3 GAS RISER DIAGRAM
 N.T.S.

ROOF


FLOOR

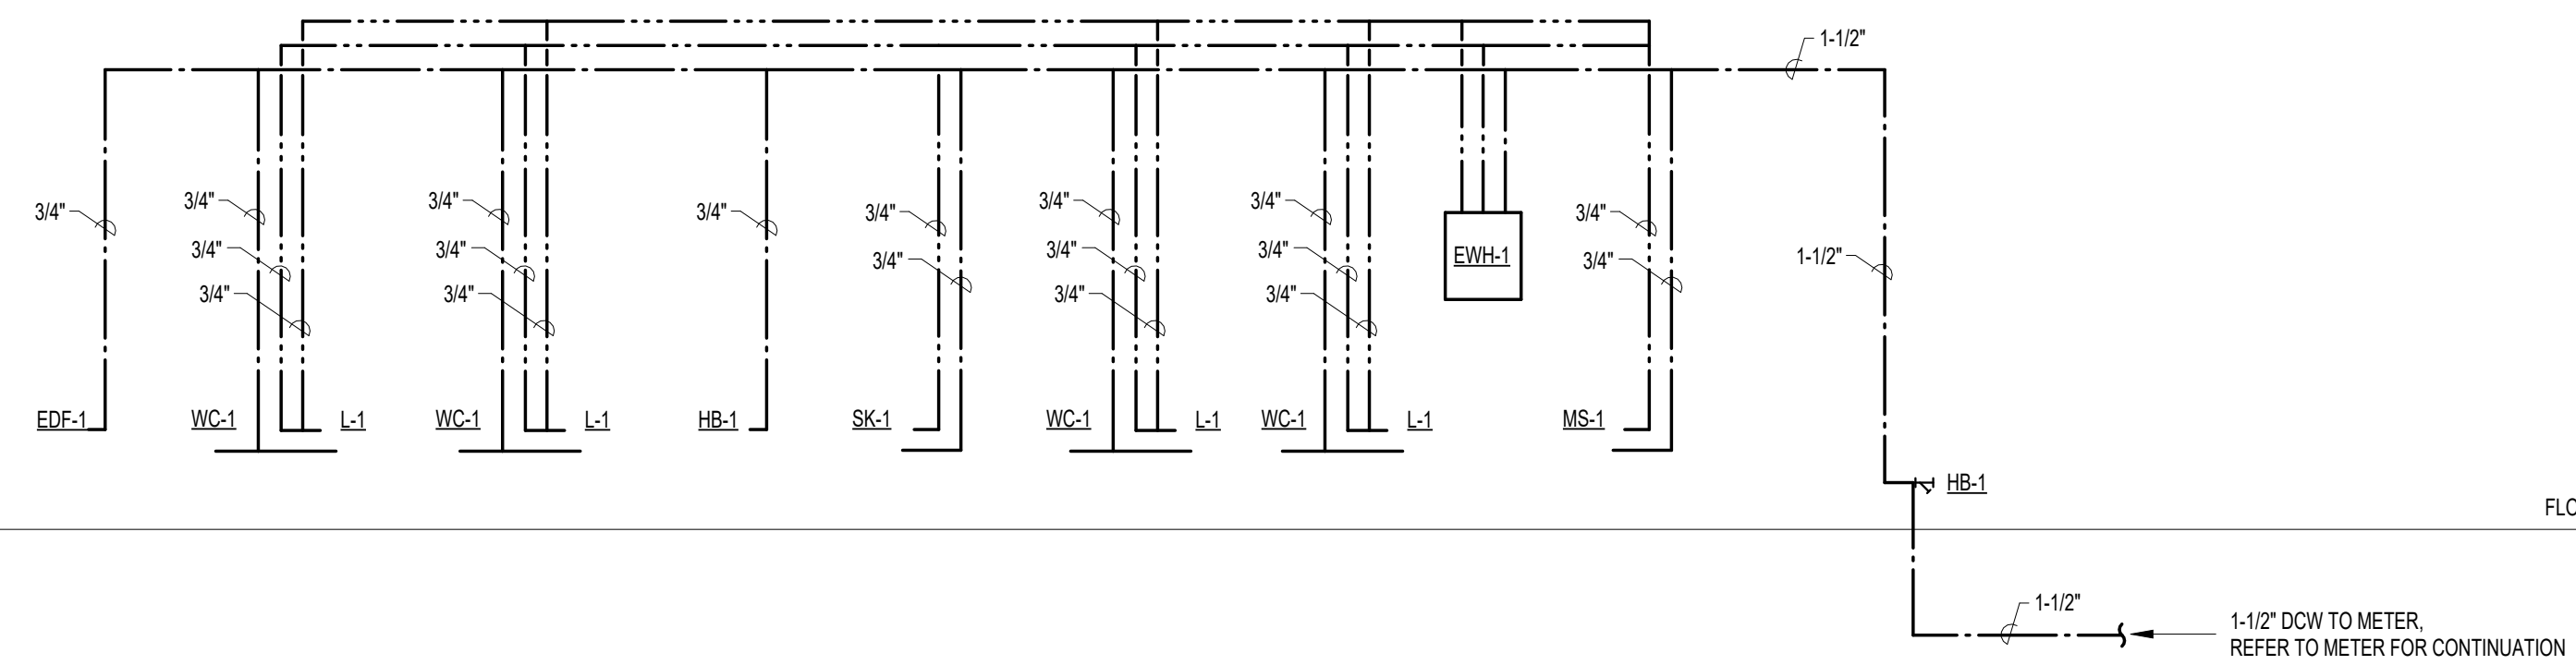

2 DOMESTIC WATER RISER DIAGRAM
 N.T.S.

ROOF

FLOOR

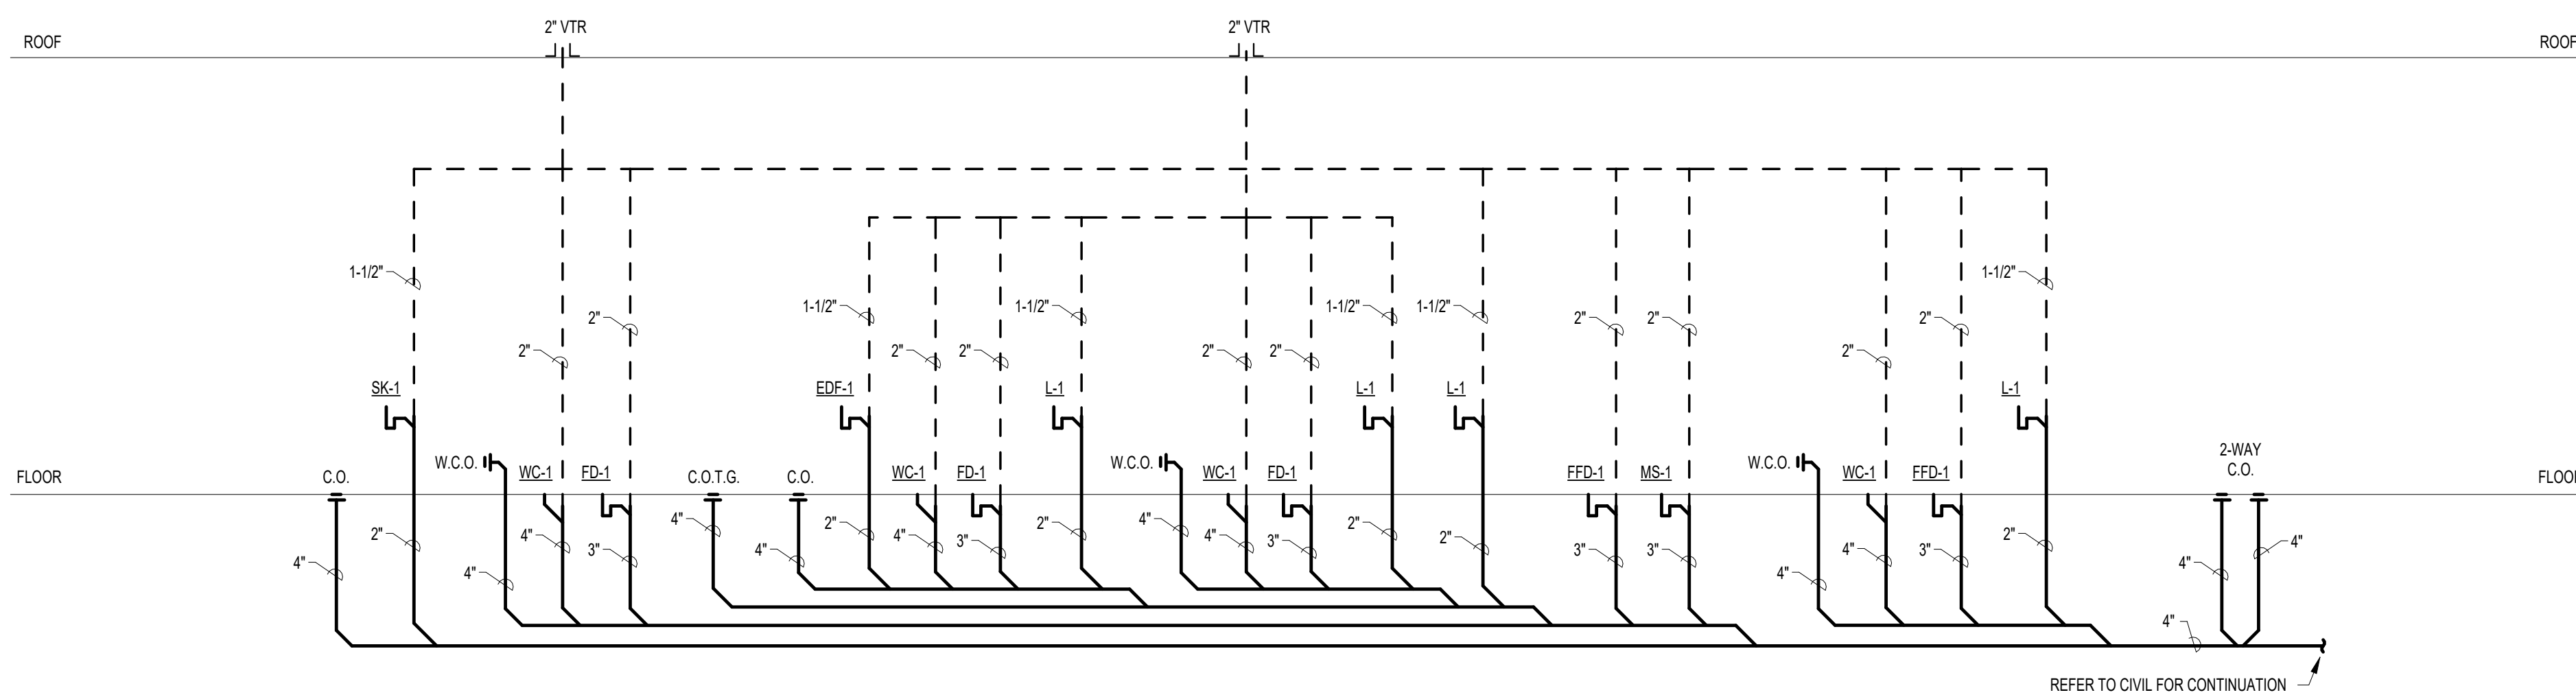

1 SAN WASTE & VENT RISER DIAGRAM
 N.T.S.

ISSUED FOR CLIENT APPROVAL	DATE
ISSUED FOR BIDDING	
ISSUED FOR PERMIT	
ISSUED FOR CONSTRUCTION	

REVISIONS

MARK	DESCRIPTION	DATE
	ISSUE FOR BID	04/07/2026

The information, ideas, designs, details, layouts, techniques, features, arrangements, plans, sequences, dimensions, allowances, tolerances, conceptions, specifications, intentions, technology or embodiments, as illustrated, arranged, displayed, noted, recorded, indicated, represented, disclosed, evidenced, detailed or otherwise reduced to tangible form hereon, either expressly, inherently or by implication, are the confidential and proprietary information of SLI Design, Inc., and shall not be used for any purpose other than the specific project or undertaking identified on the drawing title block or legend for which they are and have been prepared by SLI Design, Inc. Any other reproduction, disclosure or use of any portion of the confidential and proprietary information of SLI Design, Inc., shall be a breach of the obligation of confidence created by the acceptance of this drawing from SLI Design, Inc. for a specific project or Contract. Any copying, duplicating, reproducing, utilization, alteration, modification, revision or change to this drawing is expressly prohibited unless done with the prior written consent or approval of SLI Design, Inc., and shall not be undertaken without receipt of such prior written approval. This drawing is loaned by SLI Design, Inc., for the limited purpose of complying with a specific Contract. The drawing remains the property of SLI Design, Inc., and shall be returned upon request or completion of the contract, unless specifically authorized by Contract, under which it was loaned.

PRINT DATE: 4/6/2026 3:54:08 PM



JONES ENGINEERS, L.P.
 Consulting Mechanical/Electrical/Plumbing Engineers
 9820 Whithorn Dr. Houston, Texas 77095 (713)222-7766
 Texas Registered Engineering Firm #F-3811

DRAWING TITLE PLUMBING RISER DIAGRAMS	
DRAWN BY JE	SHEET NO. P3.04
CHECKED BY JE	
APPROVED BY JE	